


- LEGEND
- (FE) FIRE EXTINGUISHER
 - (FACP) FIRE ALARM CALL POINT
 - (EXIT) FIRE EXIT
 - (FB) FIRE BLANKET
 - (EL) EMERGENCY LIGHTING

NOTES IN RESPECT TO APPLICATION
FOR TRANSFER TO PROVISIONS OF LICENSING
ACT 2003

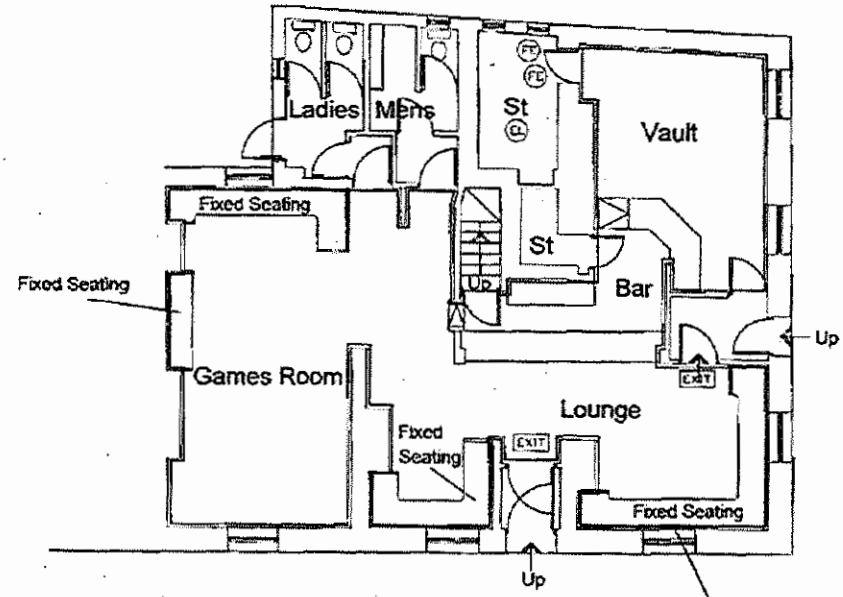

Area edged red used for sale and consumption of alcohol

| | | |
|---|-----------------|-------------|
| Client S & N Pub Enterprises | | |
| Job Title Licensing Act Reform Drawings Engineers Hotel Duckworth Street Darwen | | |
| Drawing Title Existing Floor Plans | | |
| Scale 1:100 | Date June'05 | Drawn SD |
| <small> Sutherland Pearce & Associates Ltd. Chartered Architects 200 City Road, Liverpool 0151 422111 Fax: 0151 422111 Email: enquiries@spaw.co.uk www.spaw.co.uk </small> | | |
| 3460-10 | | |