


KEY

- Ⓢ FIRE EXTINGUISHER
- Ⓥ FIRE BLANKET
- Ⓧ ILLUMINATED 'EXIT' SIGN WITH DIRECTIONAL ARROW

NOTES

- 2 OFF FIRE EXTINGUISHER IN DISABLED TOILET AREA
- EMERGENCY LIGHTING THROUGHOUT

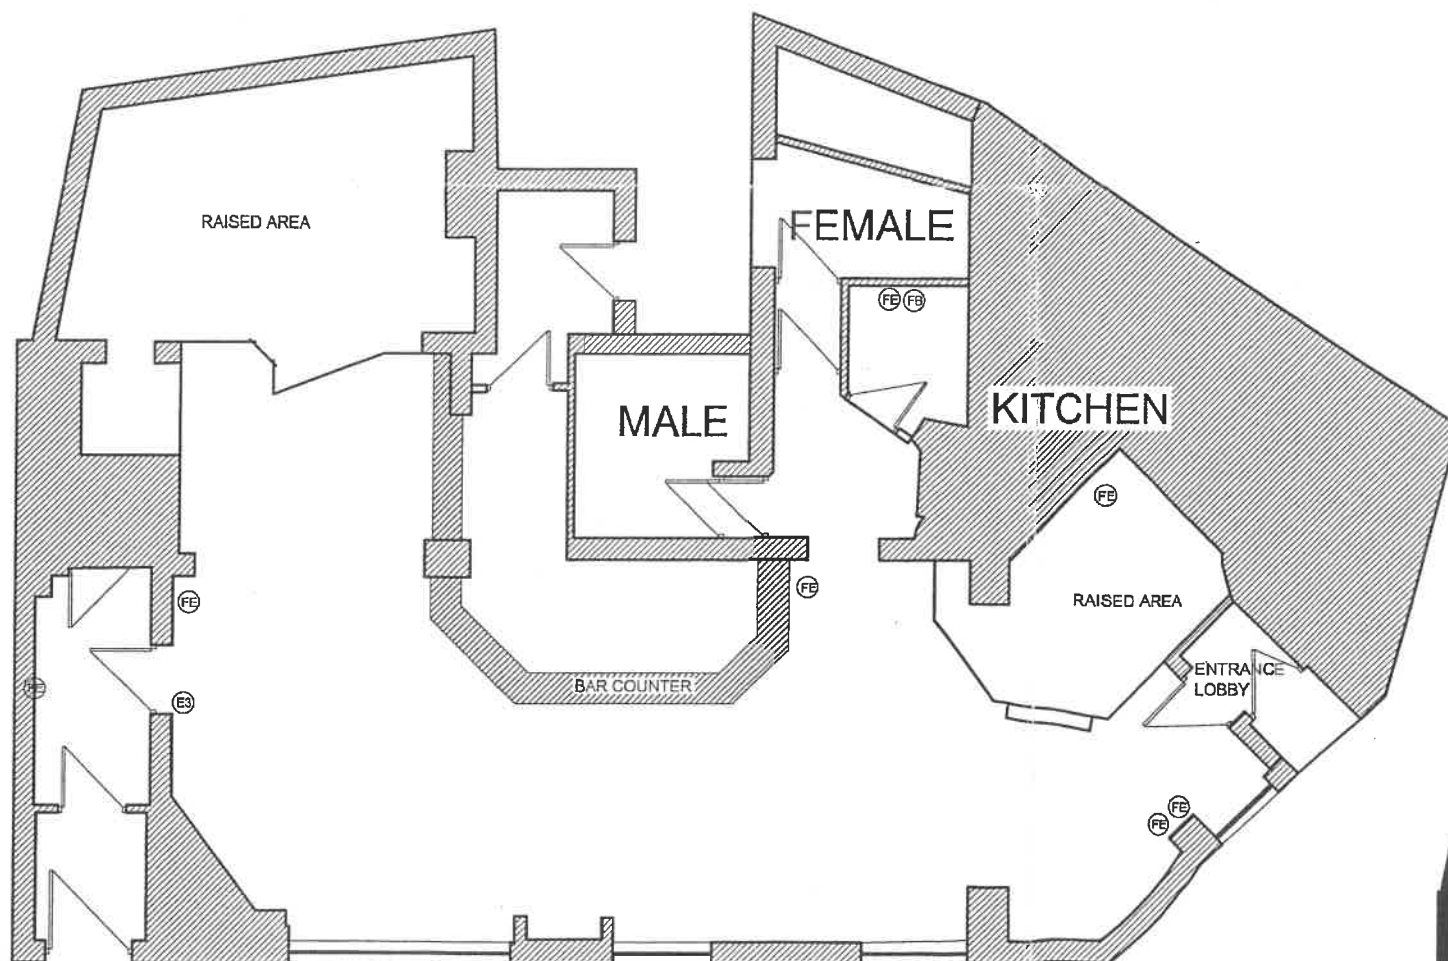

EXISTING GROUND FLOOR PLAN

Scale 1:500

A	21.7.05	REVISED FOR SURVEY	SM
REV	DATE	DETAILS	DRAWN



ROMANS
Surveyors

4 KING STREET LANE, WINNERSH, BERKSHIRE, RG41 5AS.
TELEPHONE: 0118 936 6699
35 THE AVENUE, SOUTHAMPTON, HAMPSHIRE, SO17 1XN.
TELEPHONE: 02380 820110
84 HEATH ROAD, TWICKENHAM, MIDDLESEX, TW1 4BW.
TELEPHONE: 0208 388 0330
E-MAIL ROMANS@ROMANS.CO.UK.
WWW. ROMANS.CO.UK

ON BEHALF OF

PUNCH TAVERNS

PROJECT TITLE
PIG & TRUFFLE, 49 CHURCH STREET,
RUGBY, CV21 3PT

DRAWING TITLE		SCALE	
Existing Floor Plans		1:100	
DATE		10TH JUNE 2005	
DRAWN	CHECKED	DWG NO.	REV
HEJ		400705	001

ROMANS SURVEYORS ARE PART OF
THE ROMANS GROUP INCORPORATING:
COMMERCIAL SURVEYORS ARCHITECTURAL
LAND & NEW HOMES FLOWER IFA
LETTINGS RESIDENTIAL RELOCATIONS

The
ROMANS
Group

OUTLET NO.
400705

